



ENGINEERS
ARCHITECTS
PLANNERS

449 McLaws Circle
Williamsburg, VA 23185
(757) 253-0673 VOICE
(757) 253-2319 FAX

www.djginc.com



COUNTY OF ALBEMARLE

PANTOPS
PUBLIC SAFETY
FACILITY

IFB # 2017-11223-20

CHARLOTTESVILLE,
VIRGINIA

REVISIONS

NO.	DATE	DESCRIPTION

DATE	DESCRIPTION

COMMISSION NUMBER
2160310

SCALE: **AS NOTED**

DESIGNED: **RTL**

DRAWN: **RTL**

CHECKED: **DFB**

DATE: **10.28.2016**

THE DOCUMENT CONTAINS INFORMATION PROPRIETARY TO DJG, INC. AND IS FURNISHED IN CONFIDENCE AS AN INSTRUMENT OF SERVICE FOR THE LIMITED PURPOSE OF EVALUATION, BIDDING AND REVIEW, OR CONSTRUCTION OF A SPECIFIC PROJECT. REPRODUCTION OF THIS DOCUMENT, IN WHOLE OR IN PART, OR THE MODIFICATION OF ANY DETAIL OR DESIGN WITHOUT THE EXPRESS WRITTEN CONSENT OF DJG, INC. IS PROHIBITED. ALL RIGHTS RESERVED. COPYRIGHT DJG, INC. (C) 2016.


SHEET TITLE

WALL SECTIONS


SHEET NUMBER

A-303

28 OF 68

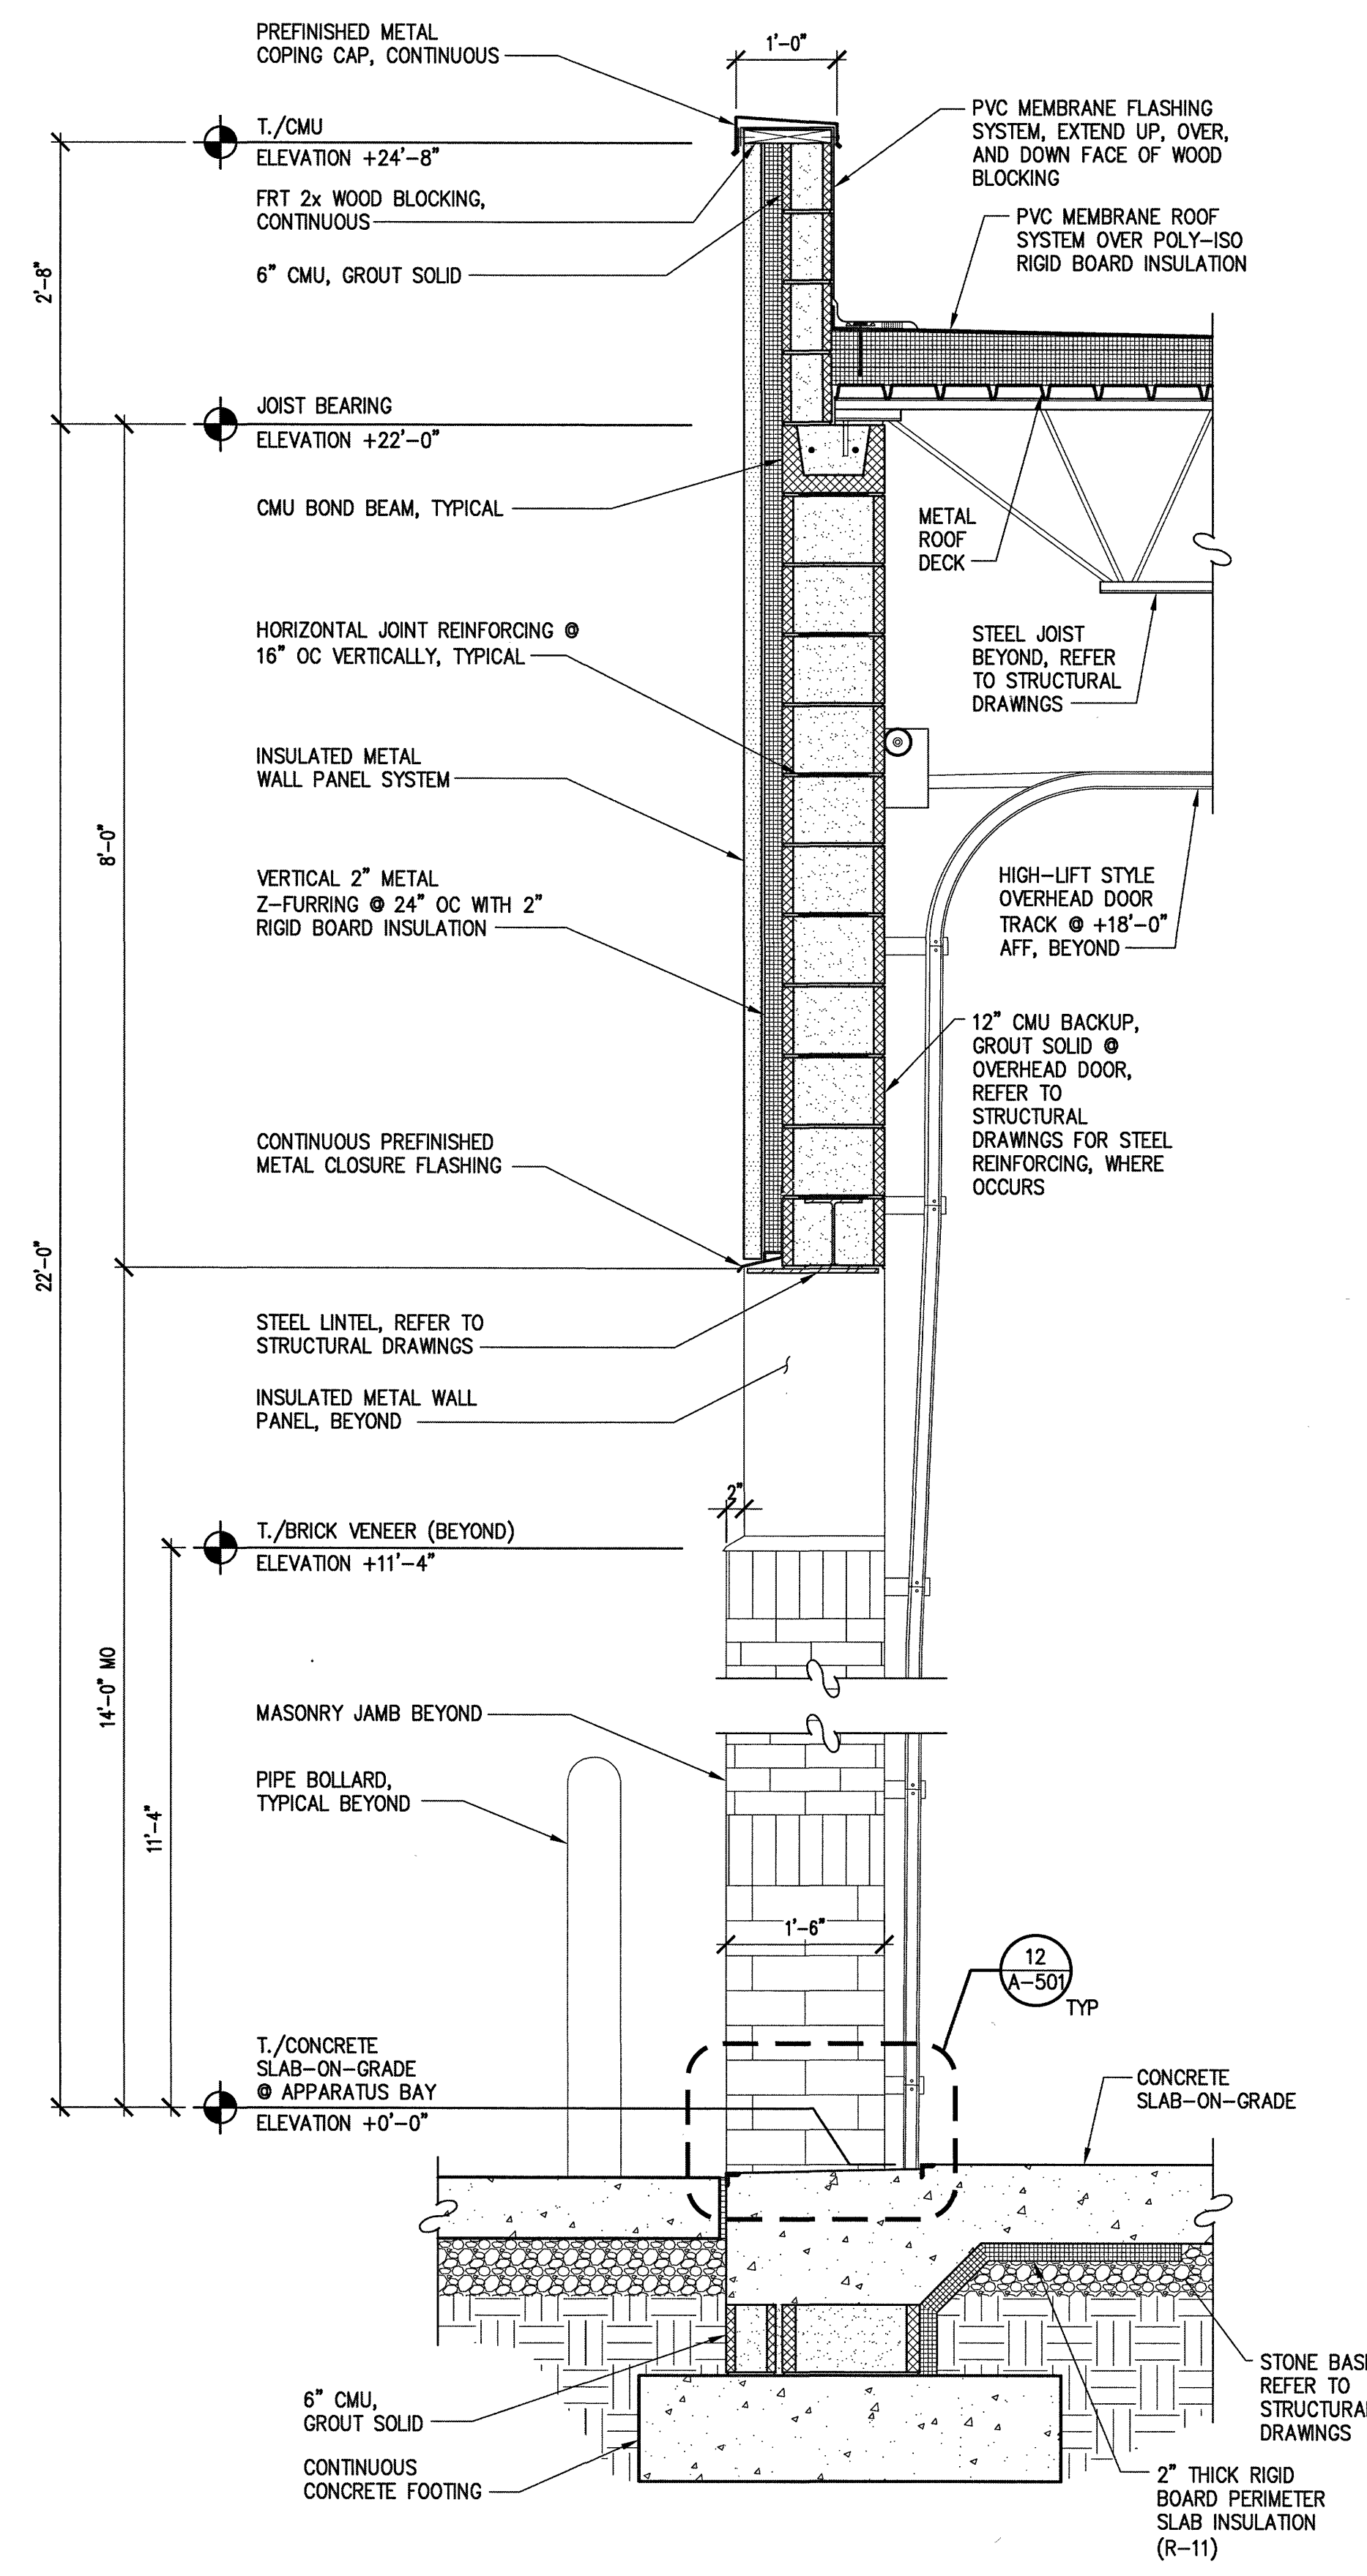

1 WALL SECTION @ APPARATUS BAY DOOR
SCALE: 3/4" = 1'-0"

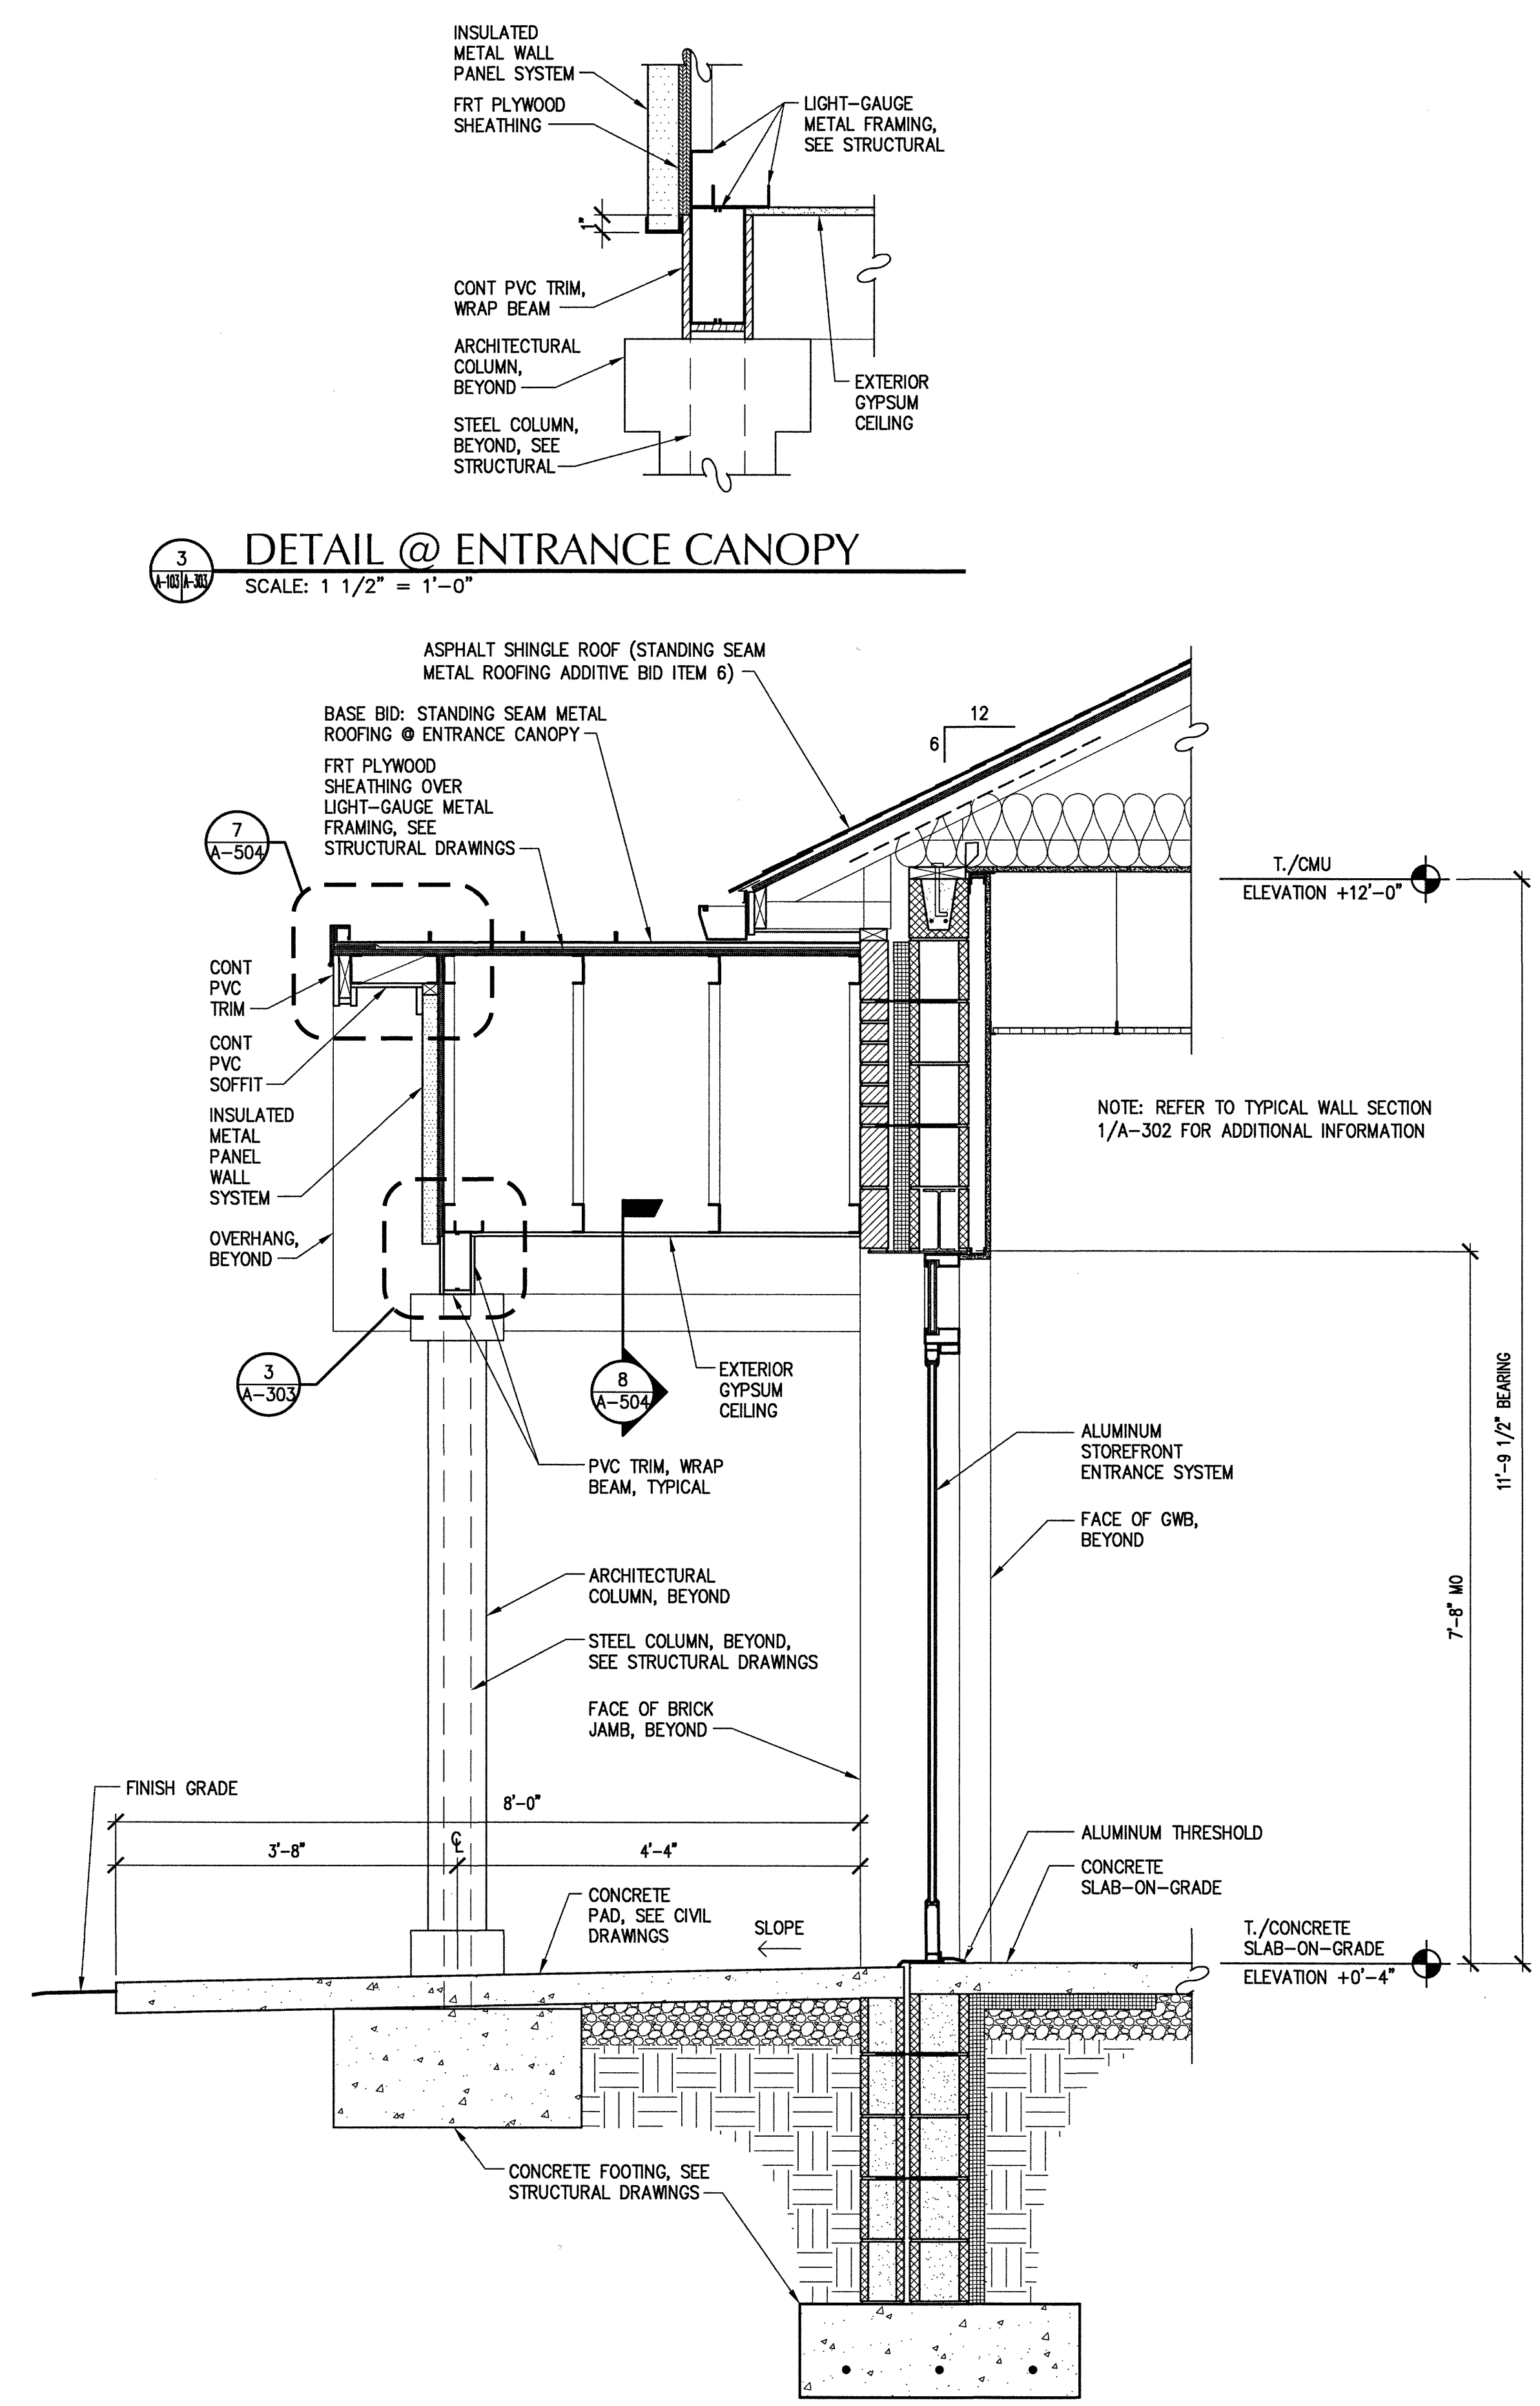

2 SECTION @ ENTRANCE CANOPY
SCALE: 3/4" = 1'-0"

