

**1 LEVEL 1 - ELECTRICAL LOW VOLTAGE PLAN - AREA C1**  
1/8" = 1'-0"

**GENERAL NOTE:**


- ALL LOW VOLTAGE CABLES ABOVE CEILING USED FOR CONTROL AND DATA SIGNALING BETWEEN EQUIPMENT SUCH AS LED LIGHTING AND LOW VOLTAGE CONTROLS SHALL BE PLENUM RATED AND SECURED FROM STRUCTURE WITH WIRE HANGERS ON 4'-0" CENTERS AND TIED TO HOOKS WITH PLENUM RATED TIE-WRAPS.

**ASBESTOS NOTE**


AN ASBESTOS INSPECTION WAS PERFORMED AND ASBESTOS-CONTAINING MATERIALS WERE FOUND. THE ASBESTOS SURVEY/INSPECTION REPORT IS AVAILABLE TO THE CONTRACTOR(S) FOR HIS INFORMATION. THE ASBESTOS-CONTAINING MATERIALS SHALL BE REMOVED BY THE OWNER PRIOR TO ANY OTHER WORK BEING PERFORMED IN THESE AREAS. IF ASBESTOS IS ENCOUNTERED STOP WORK IMMEDIATELY AND NOTIFY THE OWNER.

THESE DRAWINGS ARE BASED ON HISTORICAL DRAWINGS OF THE EXISTING BUILDING. CONTRACTOR SHALL VERIFY ALL CONDITIONS PRIOR TO THE FABRICATION OF SYSTEM. MODIFICATIONS SHALL BE MADE ONLY AFTER APPROVAL BY THE ENGINEER.



**2 LEVEL 1 - ELECTRICAL LOW VOLTAGE PLAN - AREA C2**  
1/8" = 1'-0"

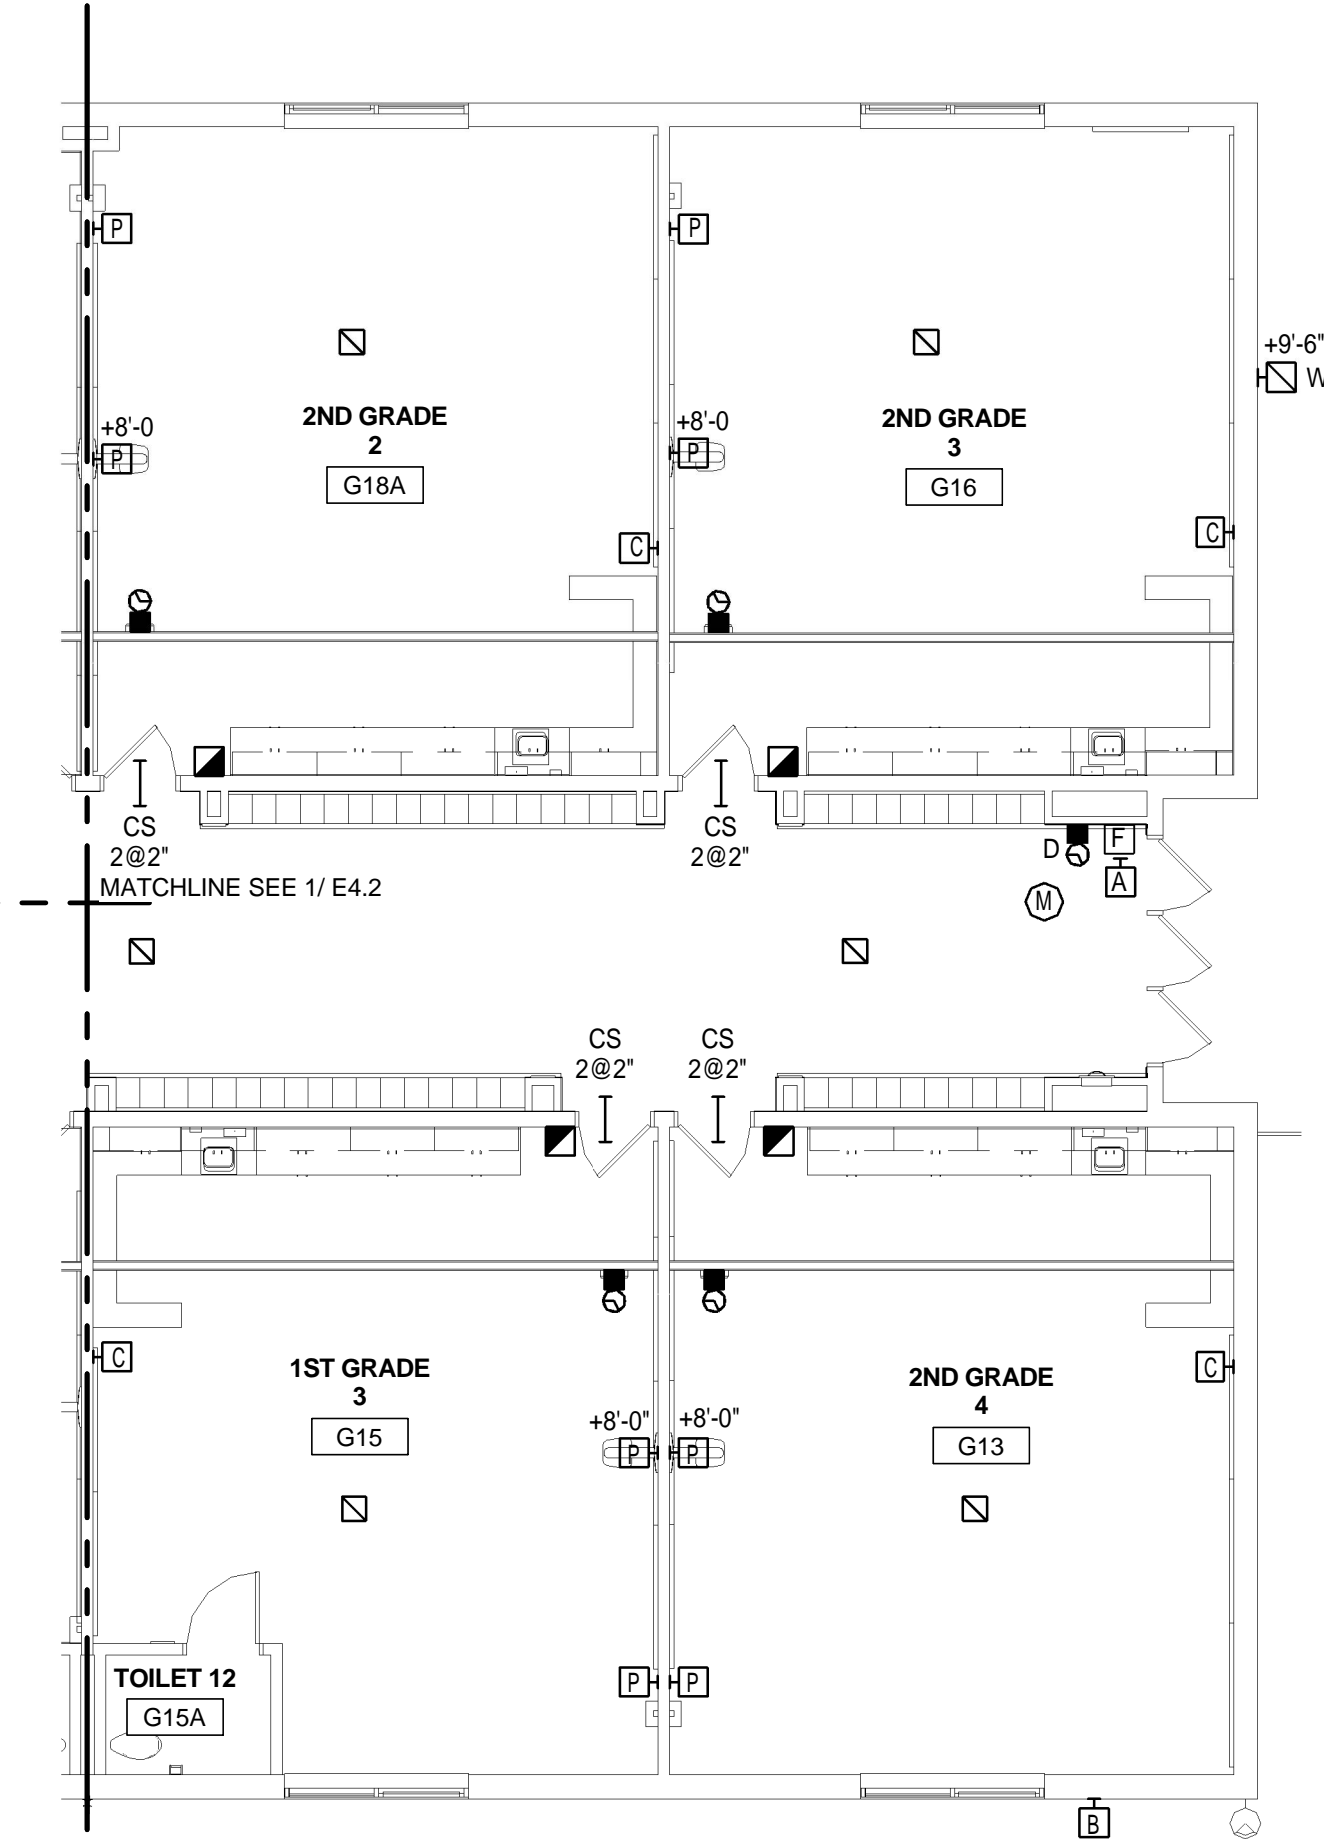

**KEY PLAN**

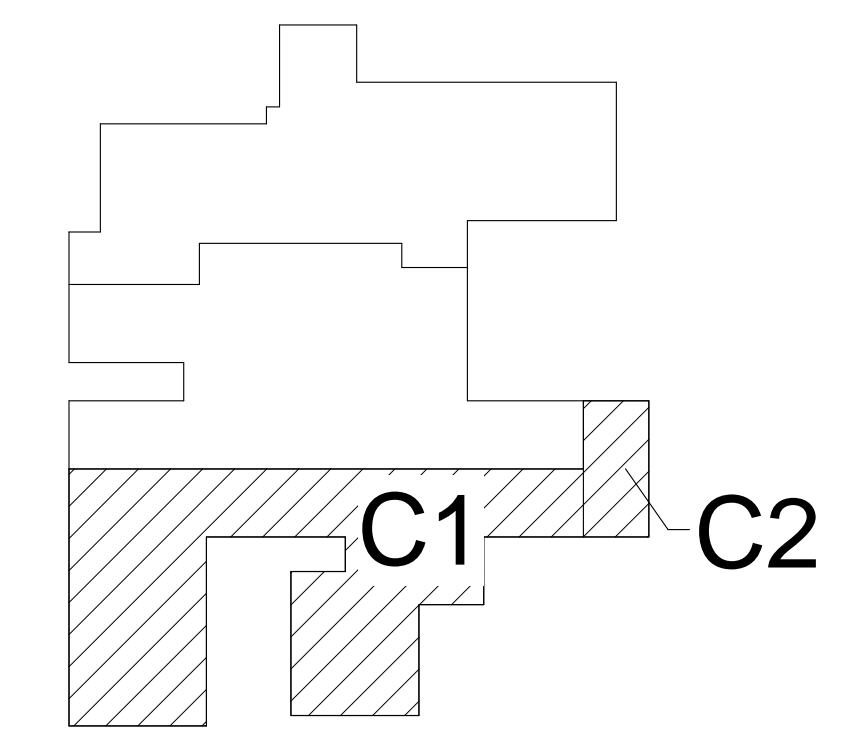

**GRAPHIC SCALE**

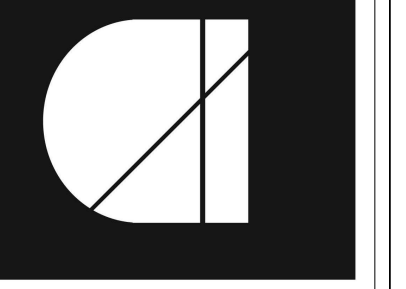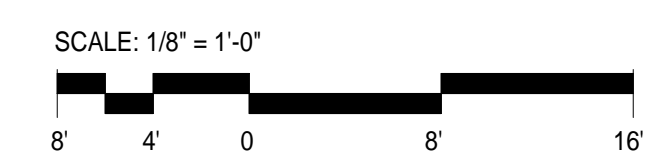

**architecture**  
incorporated

1902 campus commons drive  
suite 101  
reston, virginia 20191  
Tel: 703.476.3900  
Fax: 703.264.0733  
www.archinc.com



4932 FRONTAGE ROAD NW  
ROANOKE, VIRGINIA 24019  
(540) 365-4444  
D: JBB 16050 C: BCL

Construction Documents for:  
**ROCKINGHAM CO. PUBLIC SCHOOLS**  
**JOHN WAYLAND ES**  
**RENEWAL AND ADDITION**  
801 N. MAIN STREET,  
BRIDGEWATER, VA 22812

Project: 16034-01

Issued 02-01-2017

BID SET

Revisions

1 ADDENDUM 1 02/15/17

**LEVEL 1**  
**ELECTRICAL**  
**LOW VOLTAGE**  
**PLAN AREA C1**  
**AND C2**

Scale: As indicated  
Drawn: Author  
Checked: Checker

**E4.3**

BID SET