
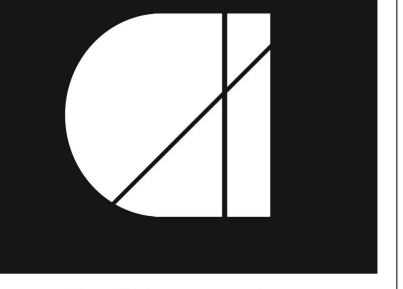
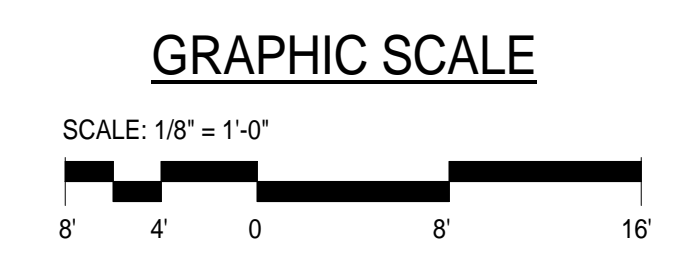


**1** LEVEL 1 - PLUMBING FOUNDATION PLAN - AREA A  
 1/8" = 1'-0"

**KEY PLAN**

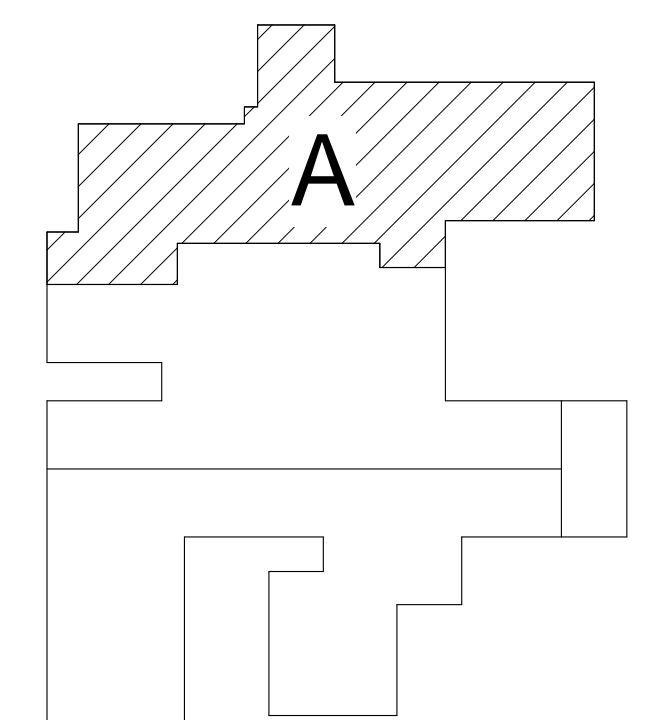

**architecture**  
 incorporated

1902 campus commons drive  
 suite 101  
 reston, virginia 20191  
 Tel: 703.476.3900  
 Fax: 703.264.0733  
 www.archinc.com



**ASCENT**  
 ENGINEERING GROUP  
 4922 FRONTAGE ROAD NW  
 ROANOKE, VIRGINIA 24019  
 (540) 265-4444  
 D: SAT 16050 C: RWD

Construction Documents for:  
**ROCKINGHAM CO. PUBLIC SCHOOLS**  
**JOHN WAYLAND ES**  
**RENEWAL AND ADDITION**  
 801 N. MAIN STREET,  
 BRIDGEWATER, VA 22812

Project: 16034-01

Issued 02-01-2017

**BID SET**

Revisions

1 ADDENDUM 1 02/15/17

**LEVEL 1**  
**PLUMBING**  
**FOUNDATION**  
**PLAN AREA A**

Scale: 1/8" = 1'-0"  
 Drawn: Author  
 Checked: Checker

**P2.1**