



SECOND FLOOR PLAN - HVAC - DEMOLITION
SCALE : 1/8" = 1'-0"

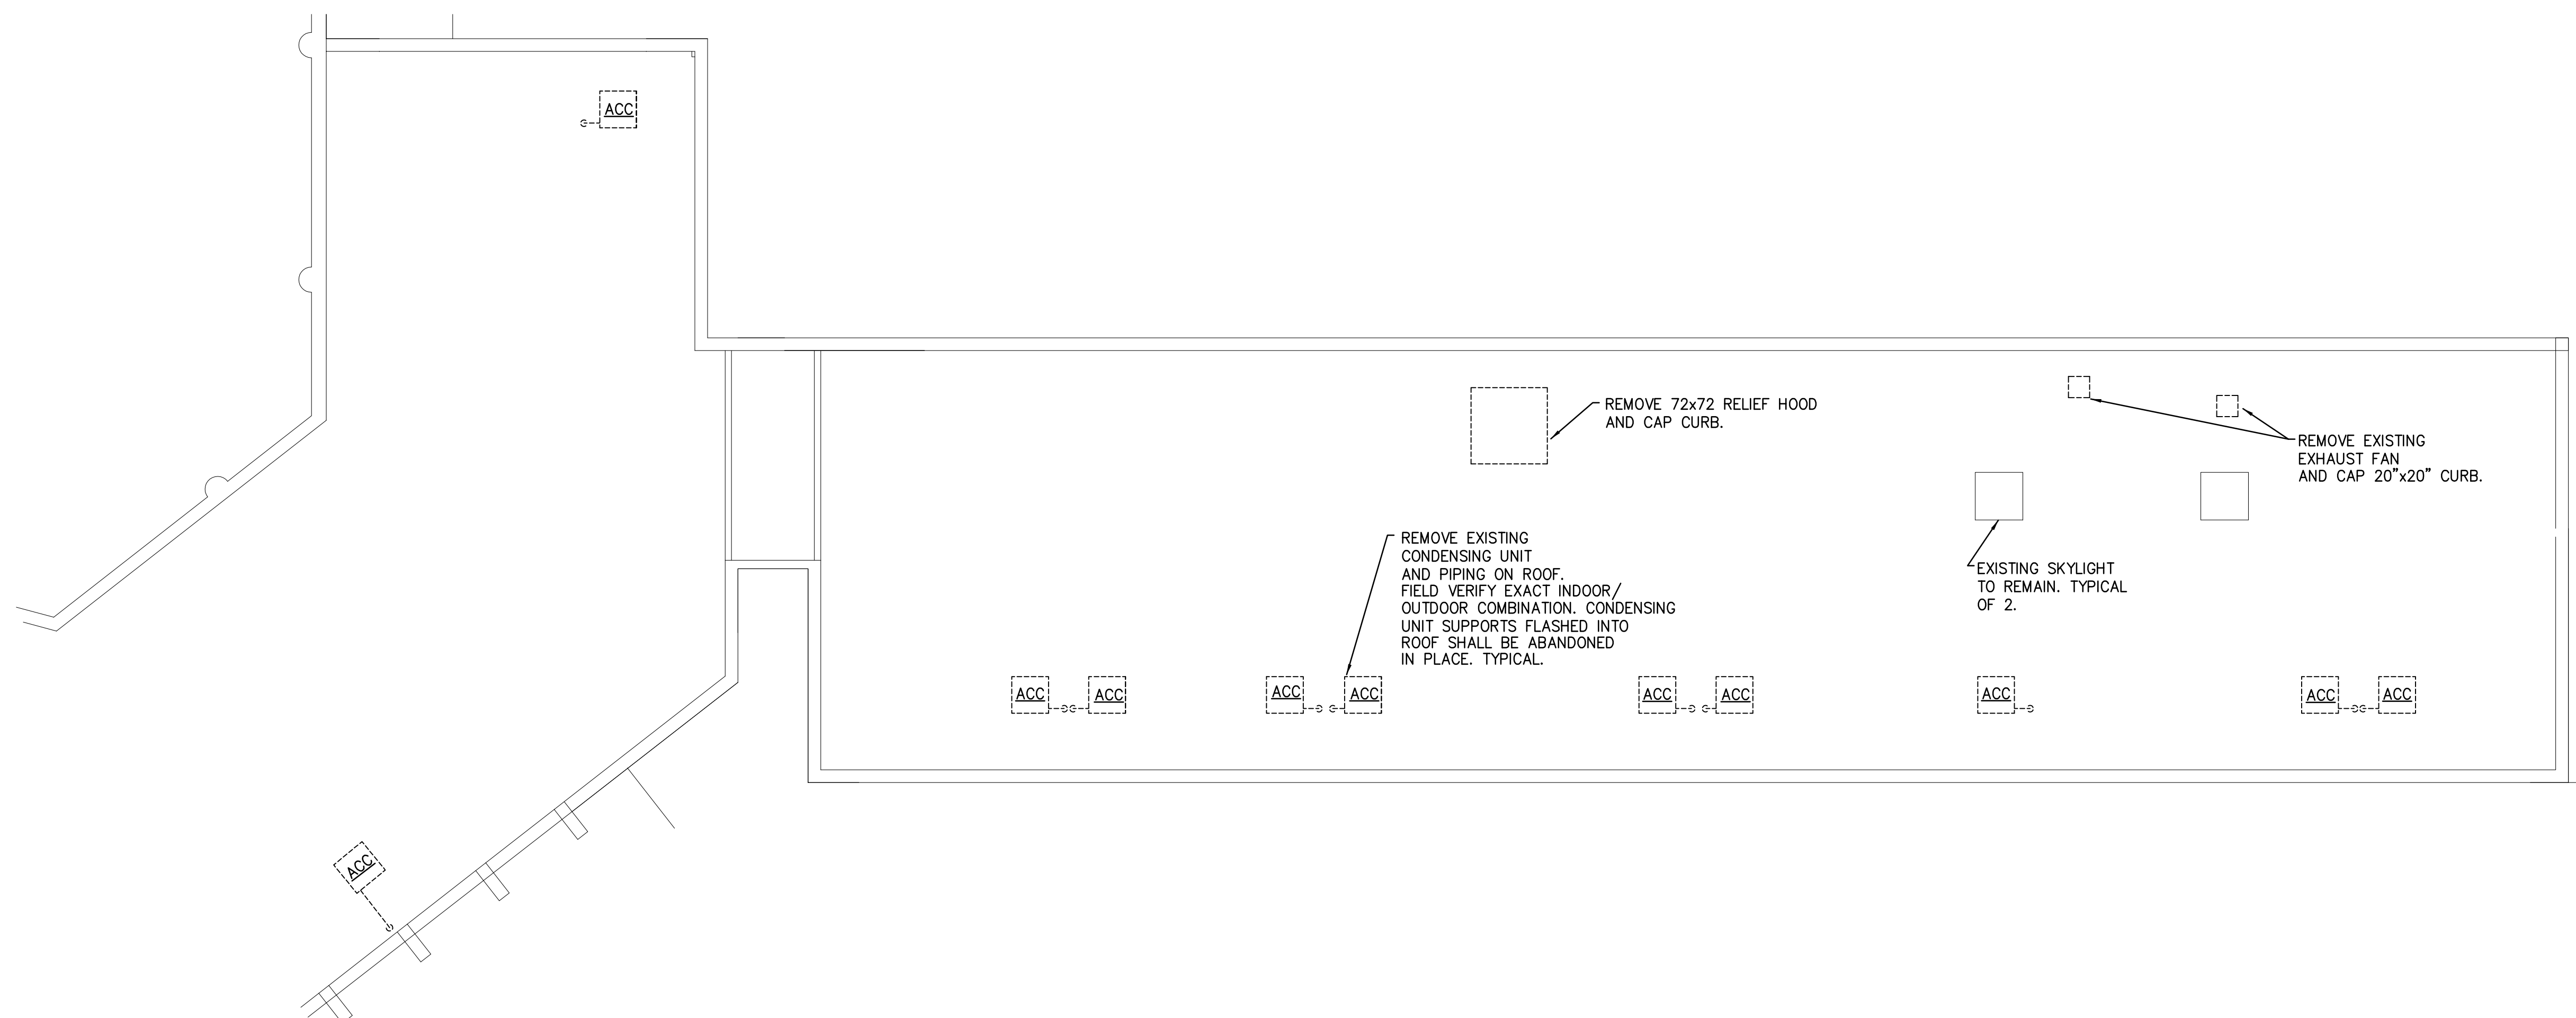

ROOF PLAN - HVAC - DEMOLITION
SCALE : 1/8" = 1'-0"

NOTE:
DEMOLITION WORK SHOWN DASHED.
EXISTING WORK SHOWN LIGHT.

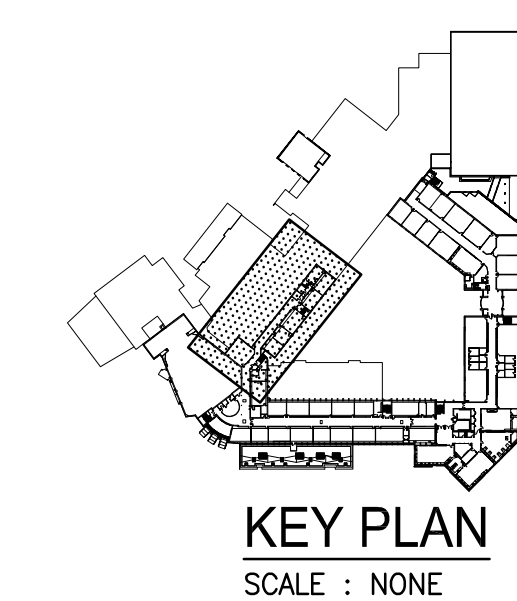

**AHS
MODERNIZATION/
HVAC UPGRADE**

ALBEMARLE COUNTY
PUBLIC SCHOOLS
2775 HYDRAULIC ROAD
CHARLOTTESVILLE, VA
22901


© BCWH, Inc.
Material included herein is owned by copyright. Use of this work in whole or in part is forbidden without the expressed written consent of BCWH, Inc.

PROJECT NUMBER:
2016.40

PROJECT MANAGER:
TAR

DRAWN BY:
TAR III

ISSUE DATE:
3/24/2017
BID DOCUMENTS
REVISIONS:

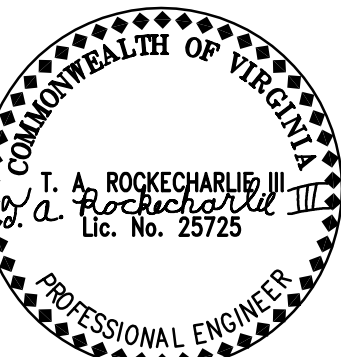

SHEET TITLE:
SECOND FLOOR PLAN
AND ROOF DEMOLITION

SHEET NUMBER:

M102