

**AHS
MODERNIZATION/
HVAC UPGRADE**

ALBEMARLE COUNTY
PUBLIC SCHOOLS

2775 HYDRAULIC ROAD
CHARLOTTESVILLE, VA
22901



© BCWH, Inc.
Material included herein is owned by copyright. Use of this work in
whole or in part is forbidden without the expressed written consent of
BCWH, Inc.

PROJECT NUMBER:
2016.40

PROJECT MANAGER:
TAR

DRAWN BY:
TAR III

ISSUE DATE:
3/24/2017
BID DOCUMENTS
REVISIONS:

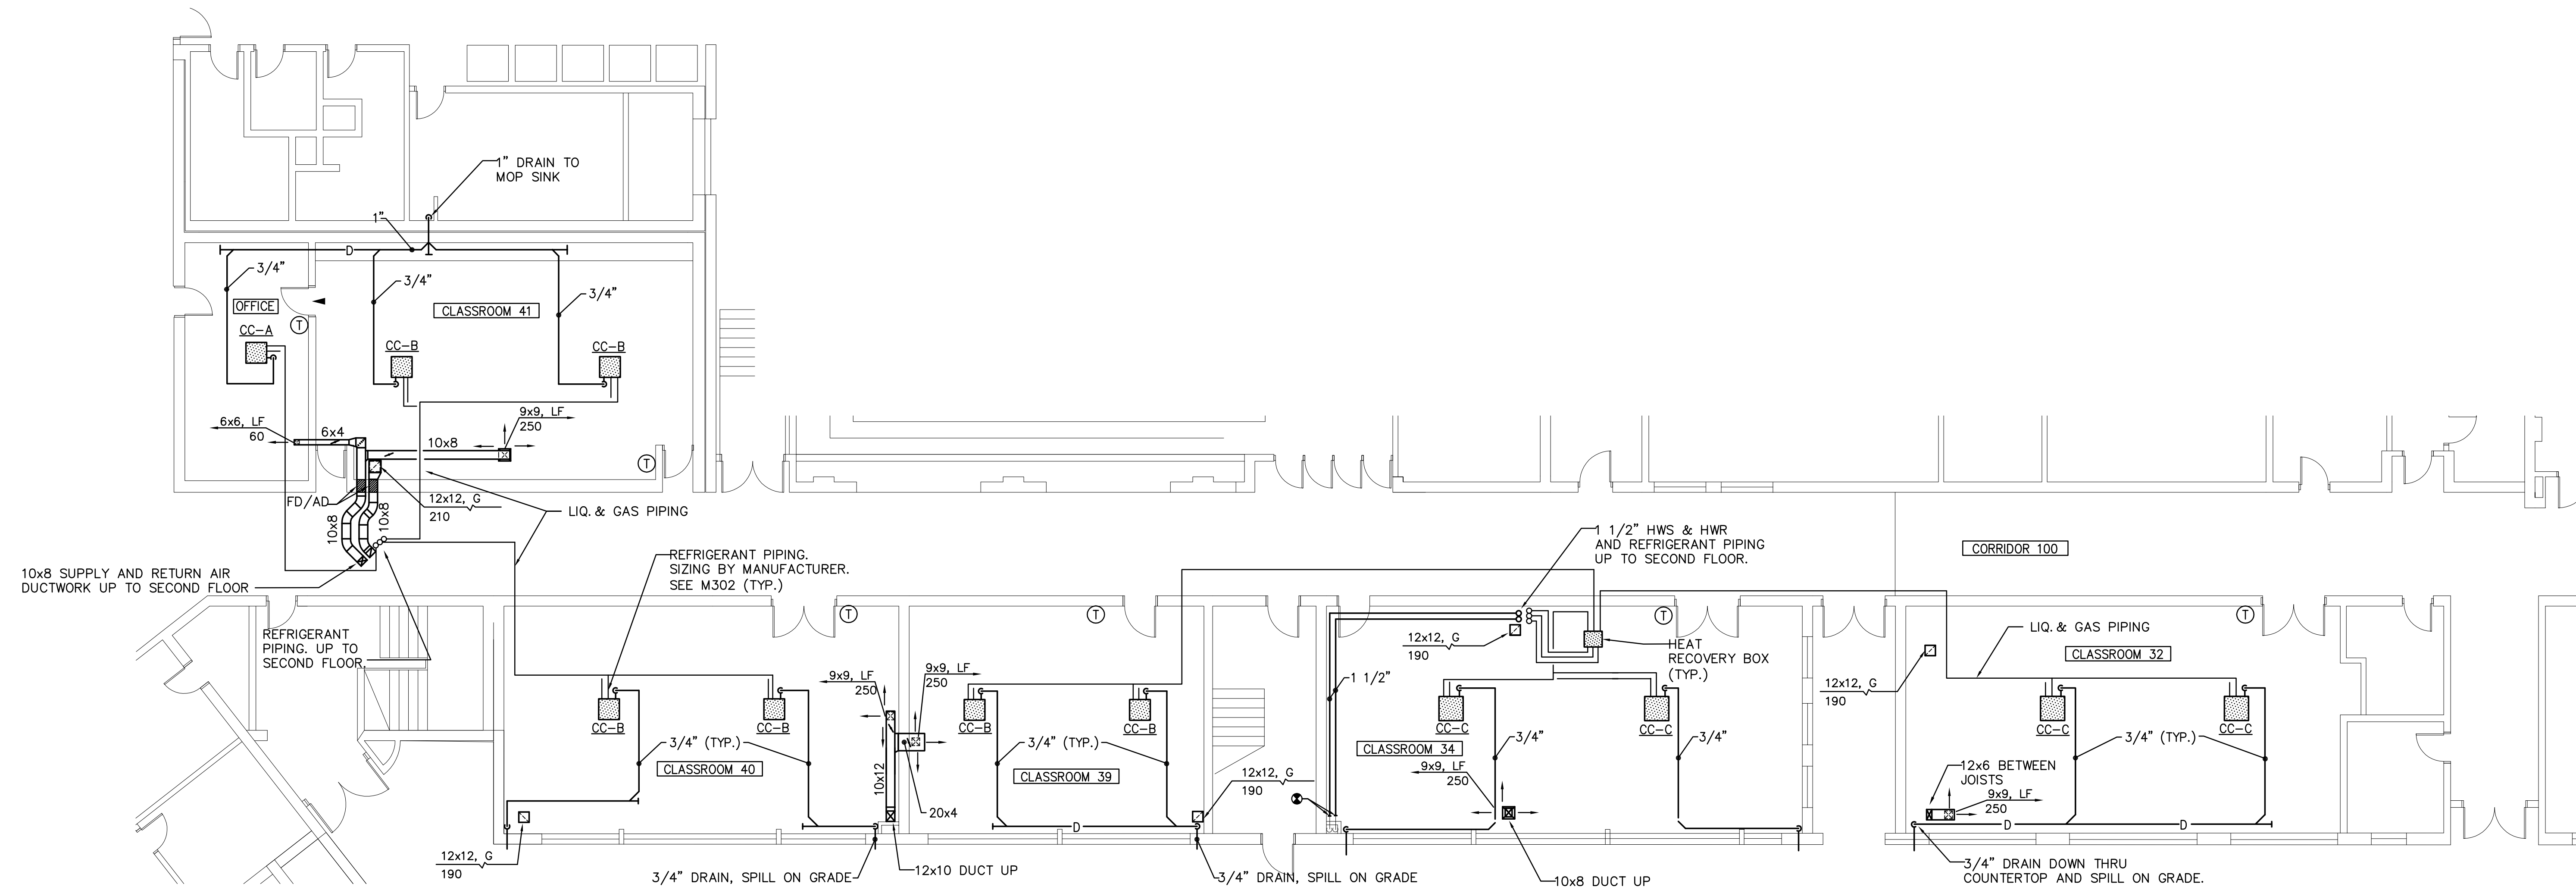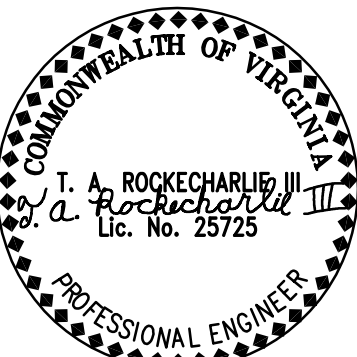

GENERAL NOTES:


RUN DUCTWORK IN BETWEEN JOISTS AND COORDINATE DUCT DROPS FROM 2ND FLOOR WITH JOISTS.

RUN REFRIGERANT PIPING TIGHT TO JOISTS.


CONCEAL VERTICAL CONDENSATE PIPING IN 18 GA. PAINTED METAL ENCLOSURE WITH CONCEALED FASTENERS WHERE NOT LOCATED IN NEW CHASES. TYPICAL.

FIRST FLOOR PLAN - HVAC - NEW WORK
SCALE : 1/8" = 1'-0"

NOTE:
DEMOLITION WORK SHOWN DASHED.
EXISTING WORK SHOWN LIGHT.
NEW WORK SHOWN DARK.

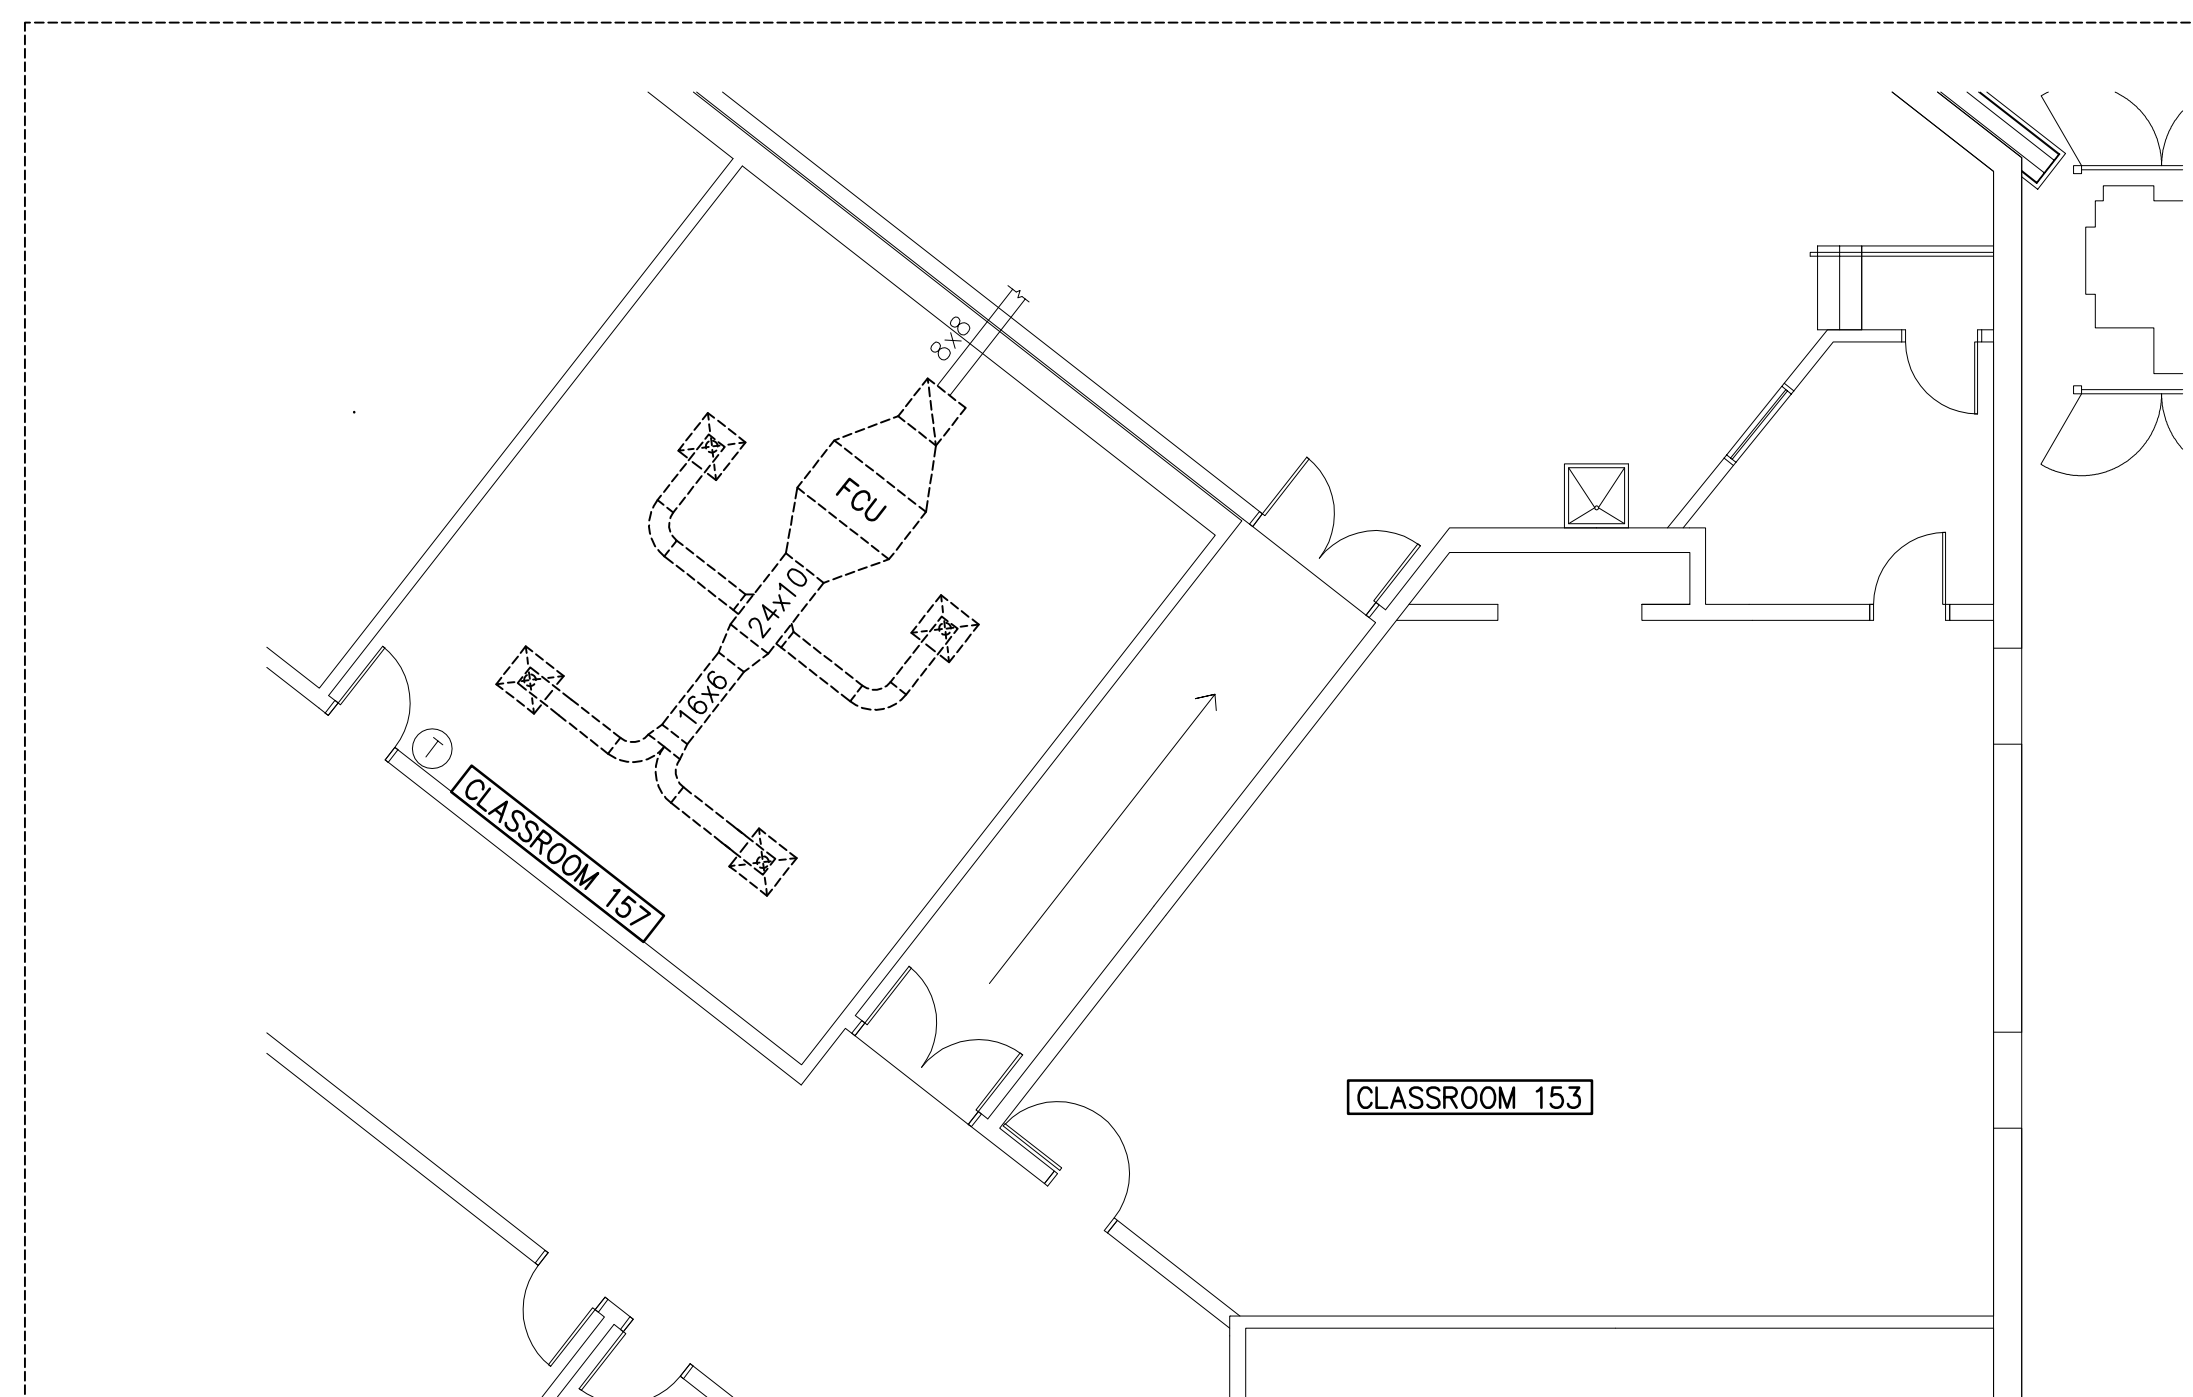


FIRST FLOOR PLAN CAD LAB - HVAC - DEMOLITION
SCALE : 1/8" = 1'-0"

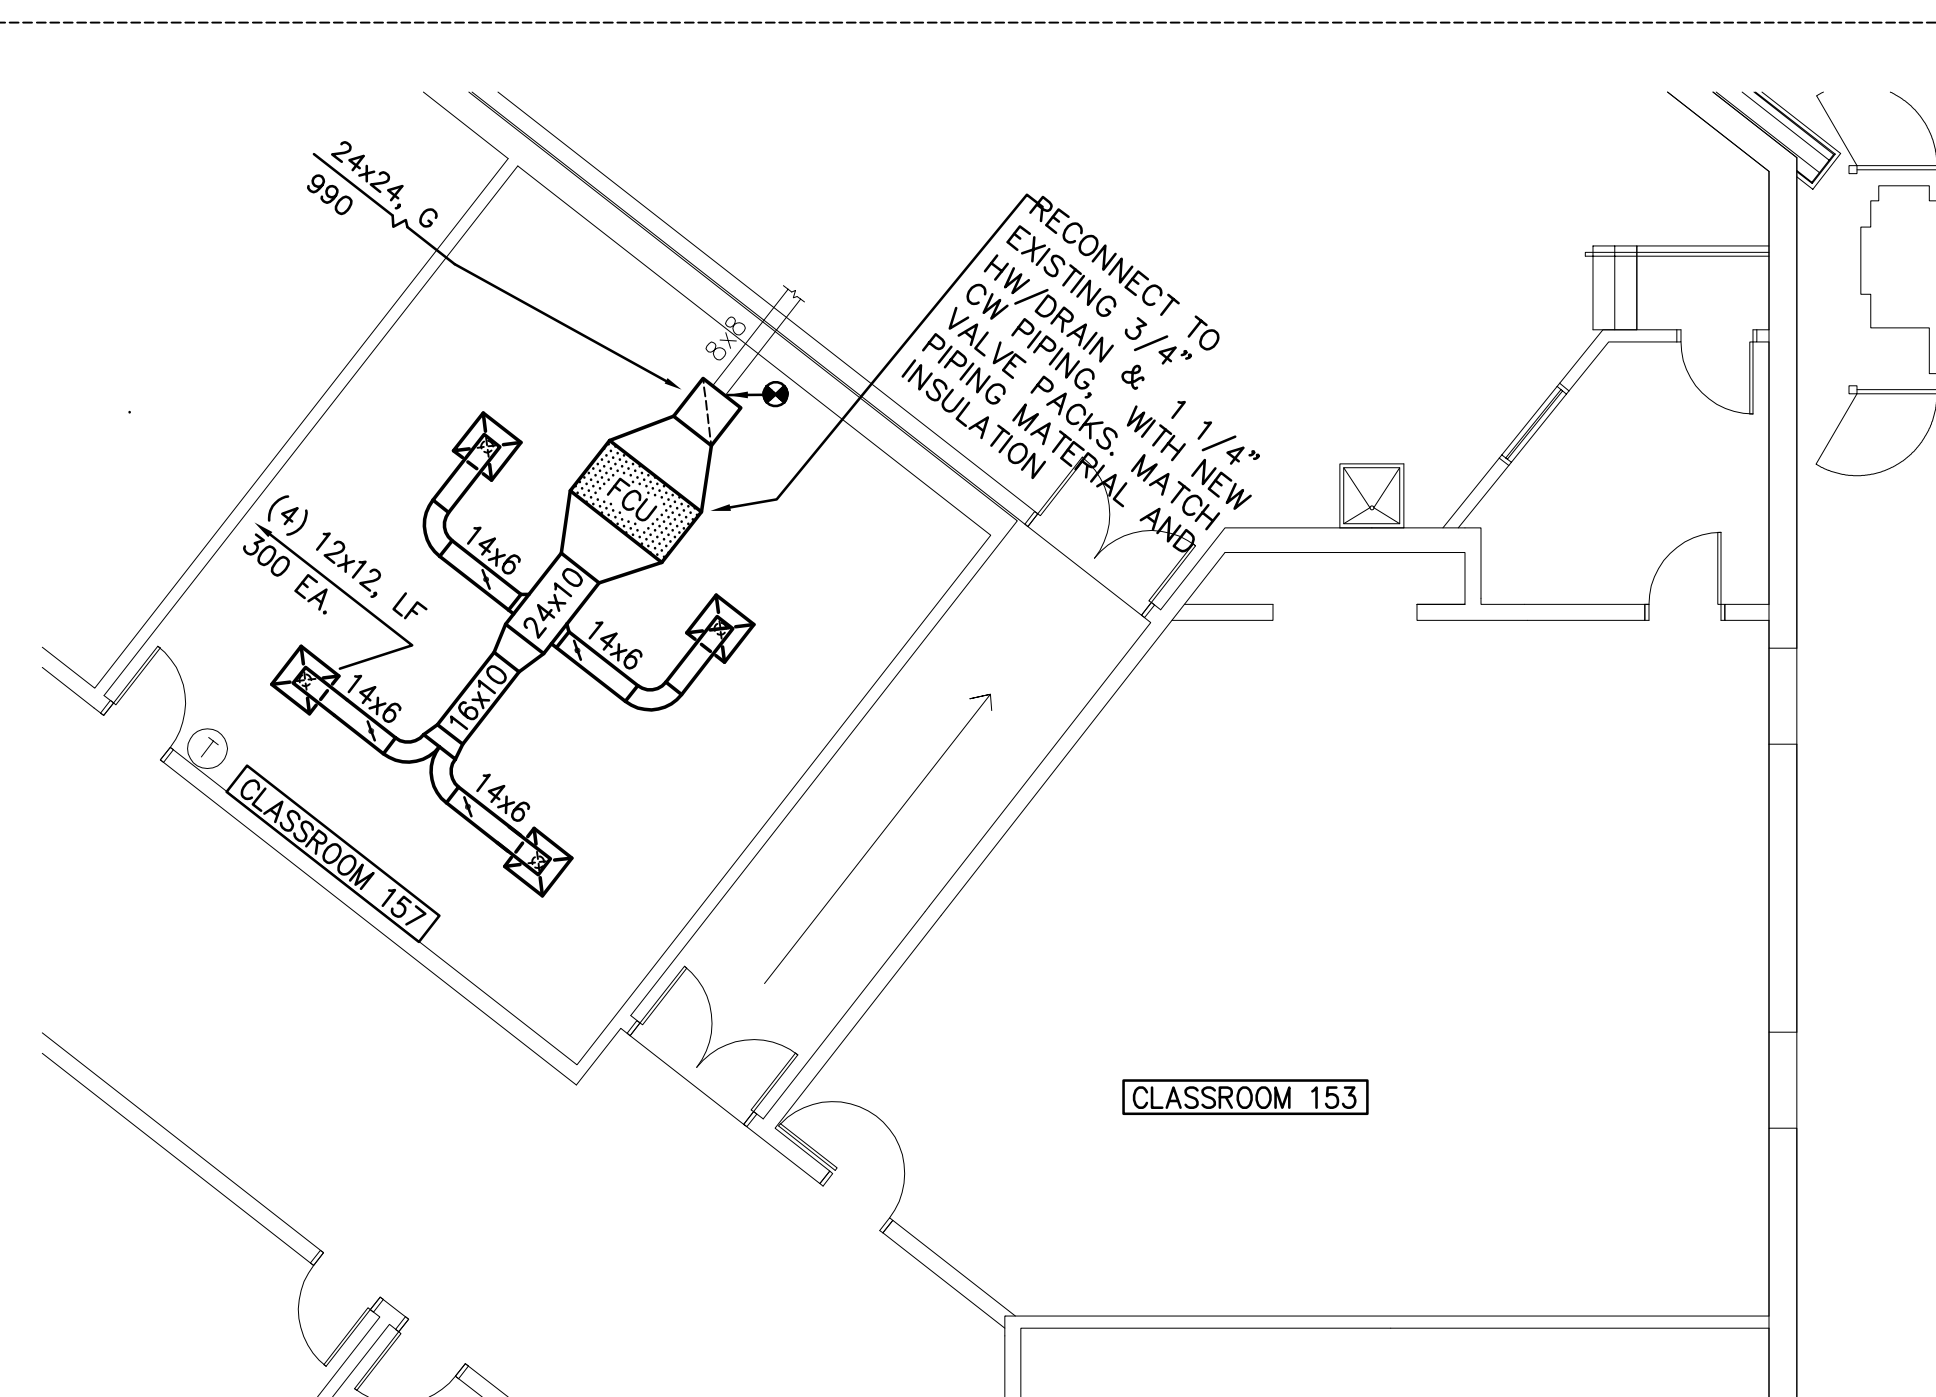

FIRST FLOOR PLAN CAD LAB - HVAC - NEW WORK
SCALE : 1/8" = 1'-0"

ADDITIVE BID ITEM #2

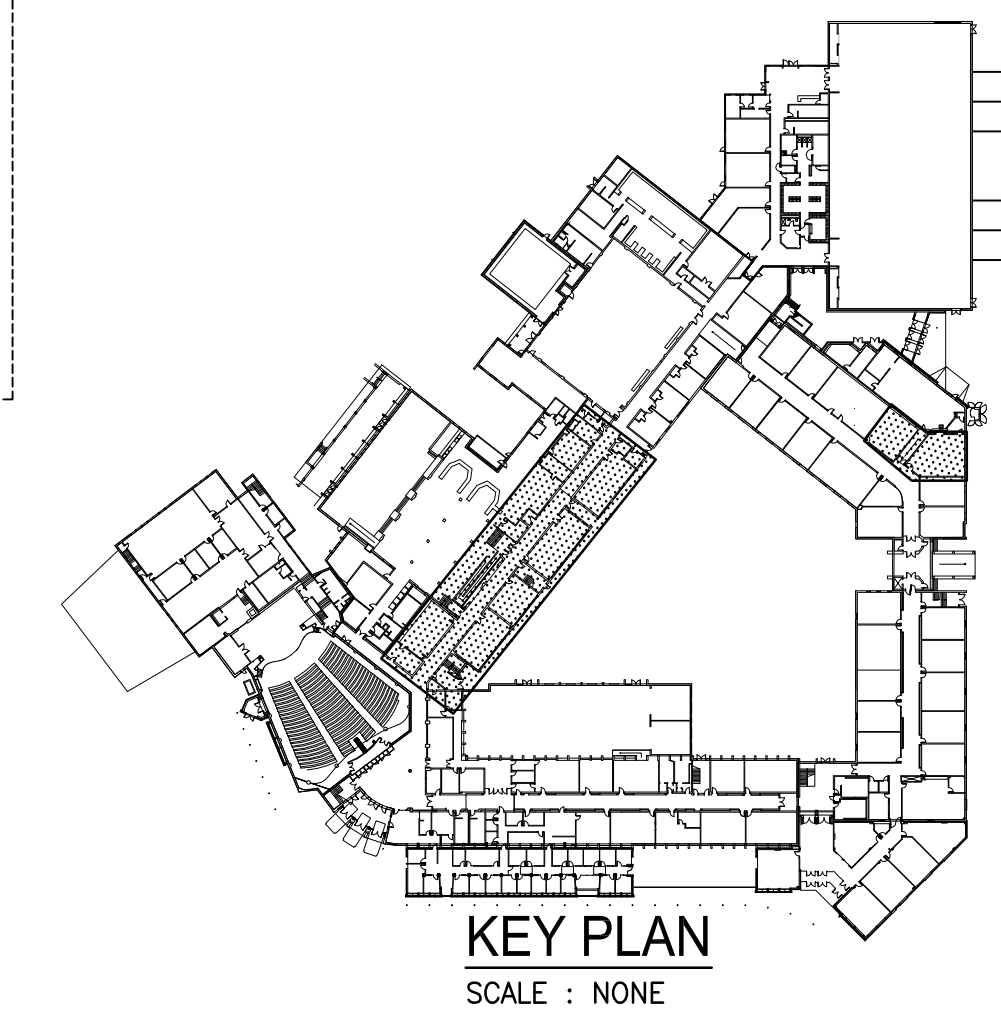

SHEET TITLE:
FIRST FLOOR PLAN
NEW WORK

SHEET NUMBER:
M201